

# SAFETECH

April 27, 2024

## Hyatt Regency Tulsa - Tulsa Ballroom South/Central - Concourse Level Tulsa, OK



Show Information	
Show Name	SAFETECH
Show Dates	April 27, 2024
Move-In	April 21, 2024
Job #	T194280424
AE	Andrea Goldberg

Inventory as of 04/19/2023


Dimension	Size	Qty	SqFt
10'x10'	100	32	3,200
Totals:		32	3,200

Floor Plan Legend	
FE	Fire Extinguisher
FS	Fire Strobe
FHC	Fire Hose Cabinet

Venue Info	
Building Name	Hyatt Regency Tulsa
Hall	Tulsa Ballroom South/Central
Floor	Concourse Level
Address	100 E 2nd St Tulsa, OK 74103

Drawing Information	
File Path	Z:\01_Floor Plans_01_S&S SHOW_FLOORPLANS\2024\SAFETECH_T194280424
File Name	SAFETECH_T194280424.dwg
Drawn By	Jayson de Nieva
Last Saved	4/13/2023 11:52 AM
Saved By	Jdenieva
Tab	Floorplan
Paper Size	ANSI full bleed A (11.00 x 8.50 Inches)
Scale	NTS

1531 Carroll Drive NW  
Atlanta, GA 30318  
(v) 404-720-8600  
(f) 404-720-8750

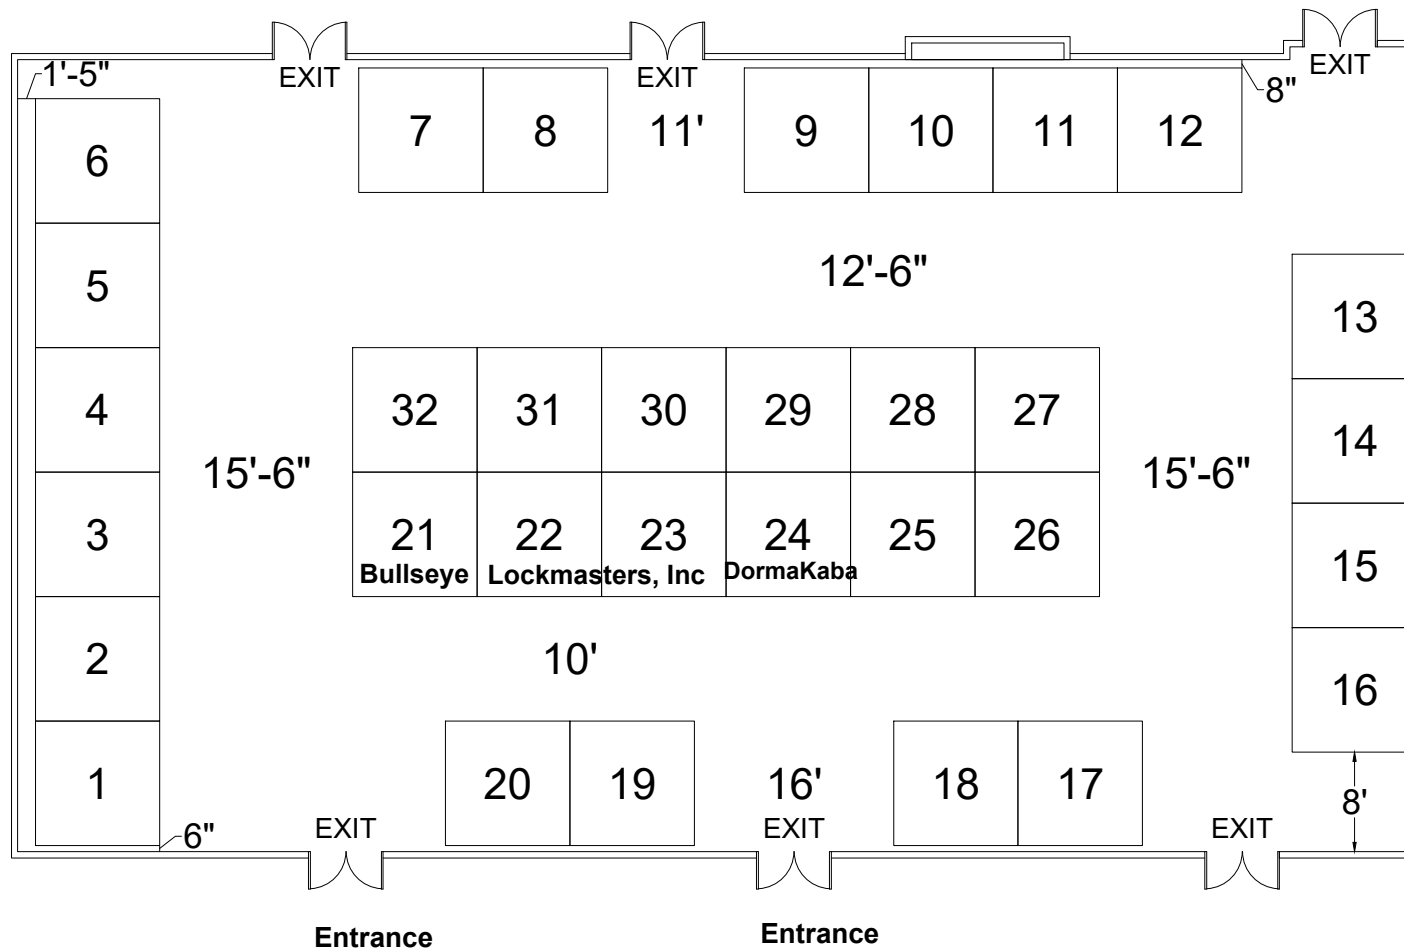

Shepard Exposition Services has made every effort to ensure the accuracy of all information contained on this floor plan. However, no warranties, either expressed or implied, are made with respect to this floor plan. Verifying the locations of building columns, utilities, or other architectural components of the facility is the sole responsibility of the exhibitor/show management.